


R/W DETAILS  
N.T.S.



OWNERSHIP TRACT No.	NRCP-0200	ROAD NRCP-0201	NRCP-0202	NRCP-0203	ROAD NRCP-0204	NRCP-0205
AREA (ha) AND LENGTH (m) OF PERMANENT EASEMENT	AREA 1.813 LENGTH 906.6	LENGTH 30.5 AREA 0.309 LENGTH 154.7	AREA 1.751 LENGTH 875.7	AREA 0.926 LENGTH 463.2	LENGTH 35.6 AREA 0.951 LENGTH 475.7	AREA 1.894 LENGTH 946.9



PIPELINE PLAN AND PROFILE IN:  
SW 1/4 Sec 17  
NW 1/4 Sec 8  
SE 1/4 Sec 8  
SW 1/4 Sec 9  
NW 1/4 Sec 4  
Tp 86 R 20 W6M

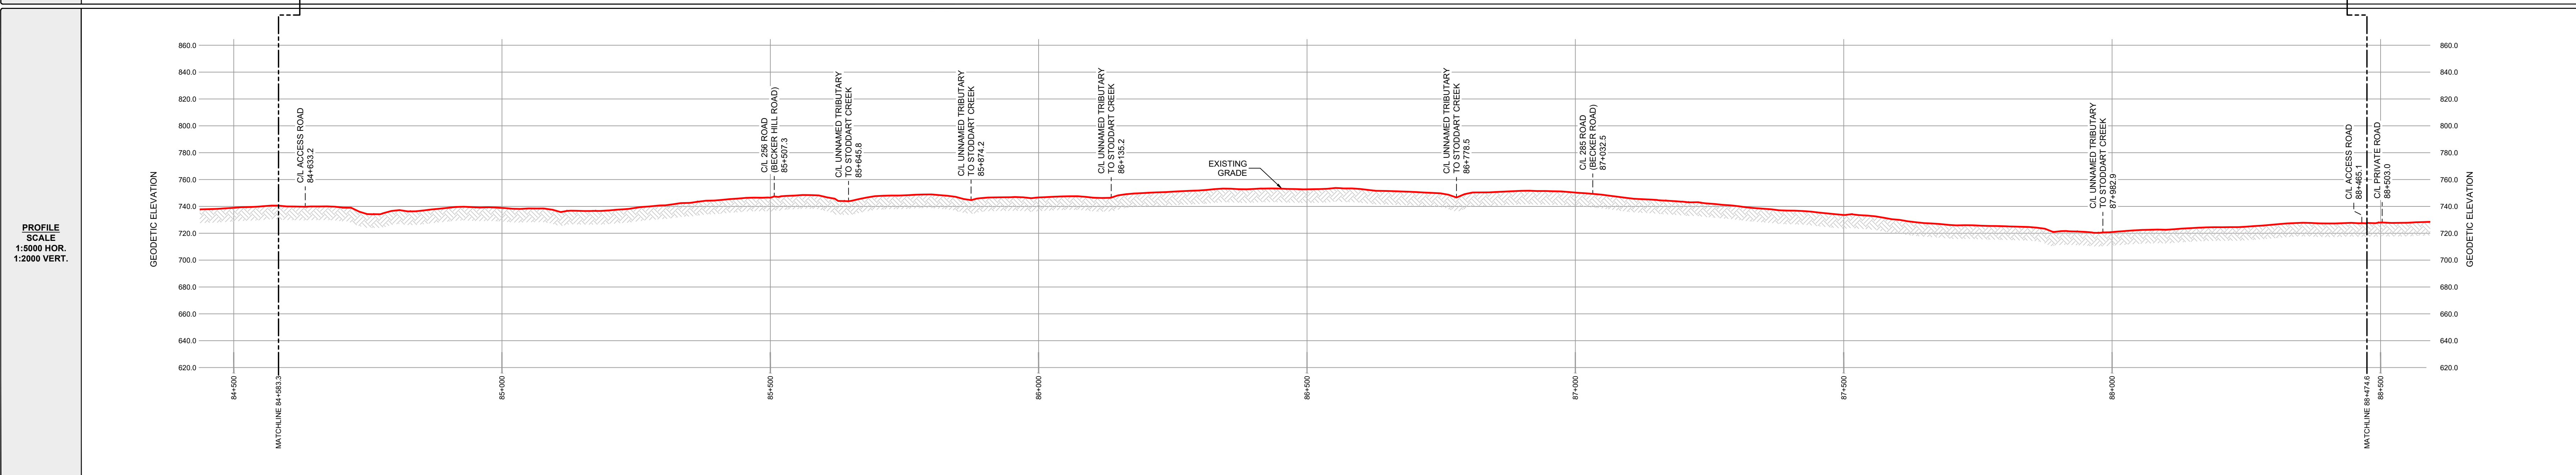

**GENERAL NOTES:**

- ALL CHAINAGES AND DIMENSIONS ARE IN METRES UNLESS NOTED OTHERWISE.
- PROFILE INFORMATION HAS BEEN OBTAINED FROM LIDAR AND FIELD SURVEY.
- CHAINAGES SHOWN ARE CONTOUR.
- THIS DOCUMENT IS NOT A PLAN OF SURVEY, BUT IS A GRAPHICAL REPRESENTATION OF THE APPROXIMATE SIZE, CONFIGURATION AND LOCATION OF PROPERTY OWNERSHIP. IT IS NOT INTENDED TO BE USED FOR LEGAL DESCRIPTIONS, CALCULATING EXACT DIMENSIONS OR PROPERTY AREAS.
- CONVERSION FACTOR FOR HECTARES TO ACRES IS: 1 HECTARE = 2.4710 ACRES.
- TYPICALLY THE RIGHT OF WAY WIDTH IS 20.0m BUT WILL VARY AT SPECIFIC LOCATIONS DUE TO ENGINEERING AND CONSTRUCTION RESTRICTIONS.
- FULL SIZE DRAWINGS ARE PLOTTED ON 707 x 1000 (B1 SIZED PAPER). REDUCED SIZE DRAWINGS ARE NOT TO SCALE.

**LEGEND:**

KILOMETRE POST:

PROPOSED PIPELINE RIGHT OF WAY:

PROPOSED VALVE SITE:

PROPERTY LINE:

A/R: ACCESS ROAD  
ha.: HECTARES  
m: METRES  
NPS: NOMINAL PIPE SIZE  
P/L: PIPELINE  
R/W: RIGHT OF WAY  
C/L: CENTRE LINE

**CER APPROVAL:**

**LAND TITLES OFFICE:**

**PLAN No.** \_\_\_\_\_

**ENTERED AND REGISTERED**

**ON** \_\_\_\_\_

**INSTRUMENT No:** \_\_\_\_\_

**A.D.REGISTRAR**

**REVISIONS:**

NO.	DESCRIPTION	DATE	DRFT	CHK	APRV
00	PLAN ISSUED	NOV. 18, 2024	JA	TM	JH

**NORTH RIVER**  
MIDSTREAM

**PLAN SHOWING:**

**Plan and Profile of NEBC Connector**  
from  
**KP 84+583.3 to 88+474.6**  
Limits of Sheet  
**SW 1/4 Sec 17 Tp 86 R 20 W6M**  
**NW 1/4 Sec 4 Tp 86 R 20 W6M**  
Peace River District - British Columbia

MIDWEST SURVEYS LAND SURVEYING LTD. 10915 ALASKA ROAD FORT ST. JOHN, BC, V1J 6P3 TEL: 250-795-3902	Project Name: NEBC Connector Project No.: C-00364 Route Reference: PB000222-MSI-GS-SPD-002_18 Document No.: PB000222-MSI-DD-MAP-227_00	Sheet No.: 26.0 REVISION <b>00</b>
--	---	--